


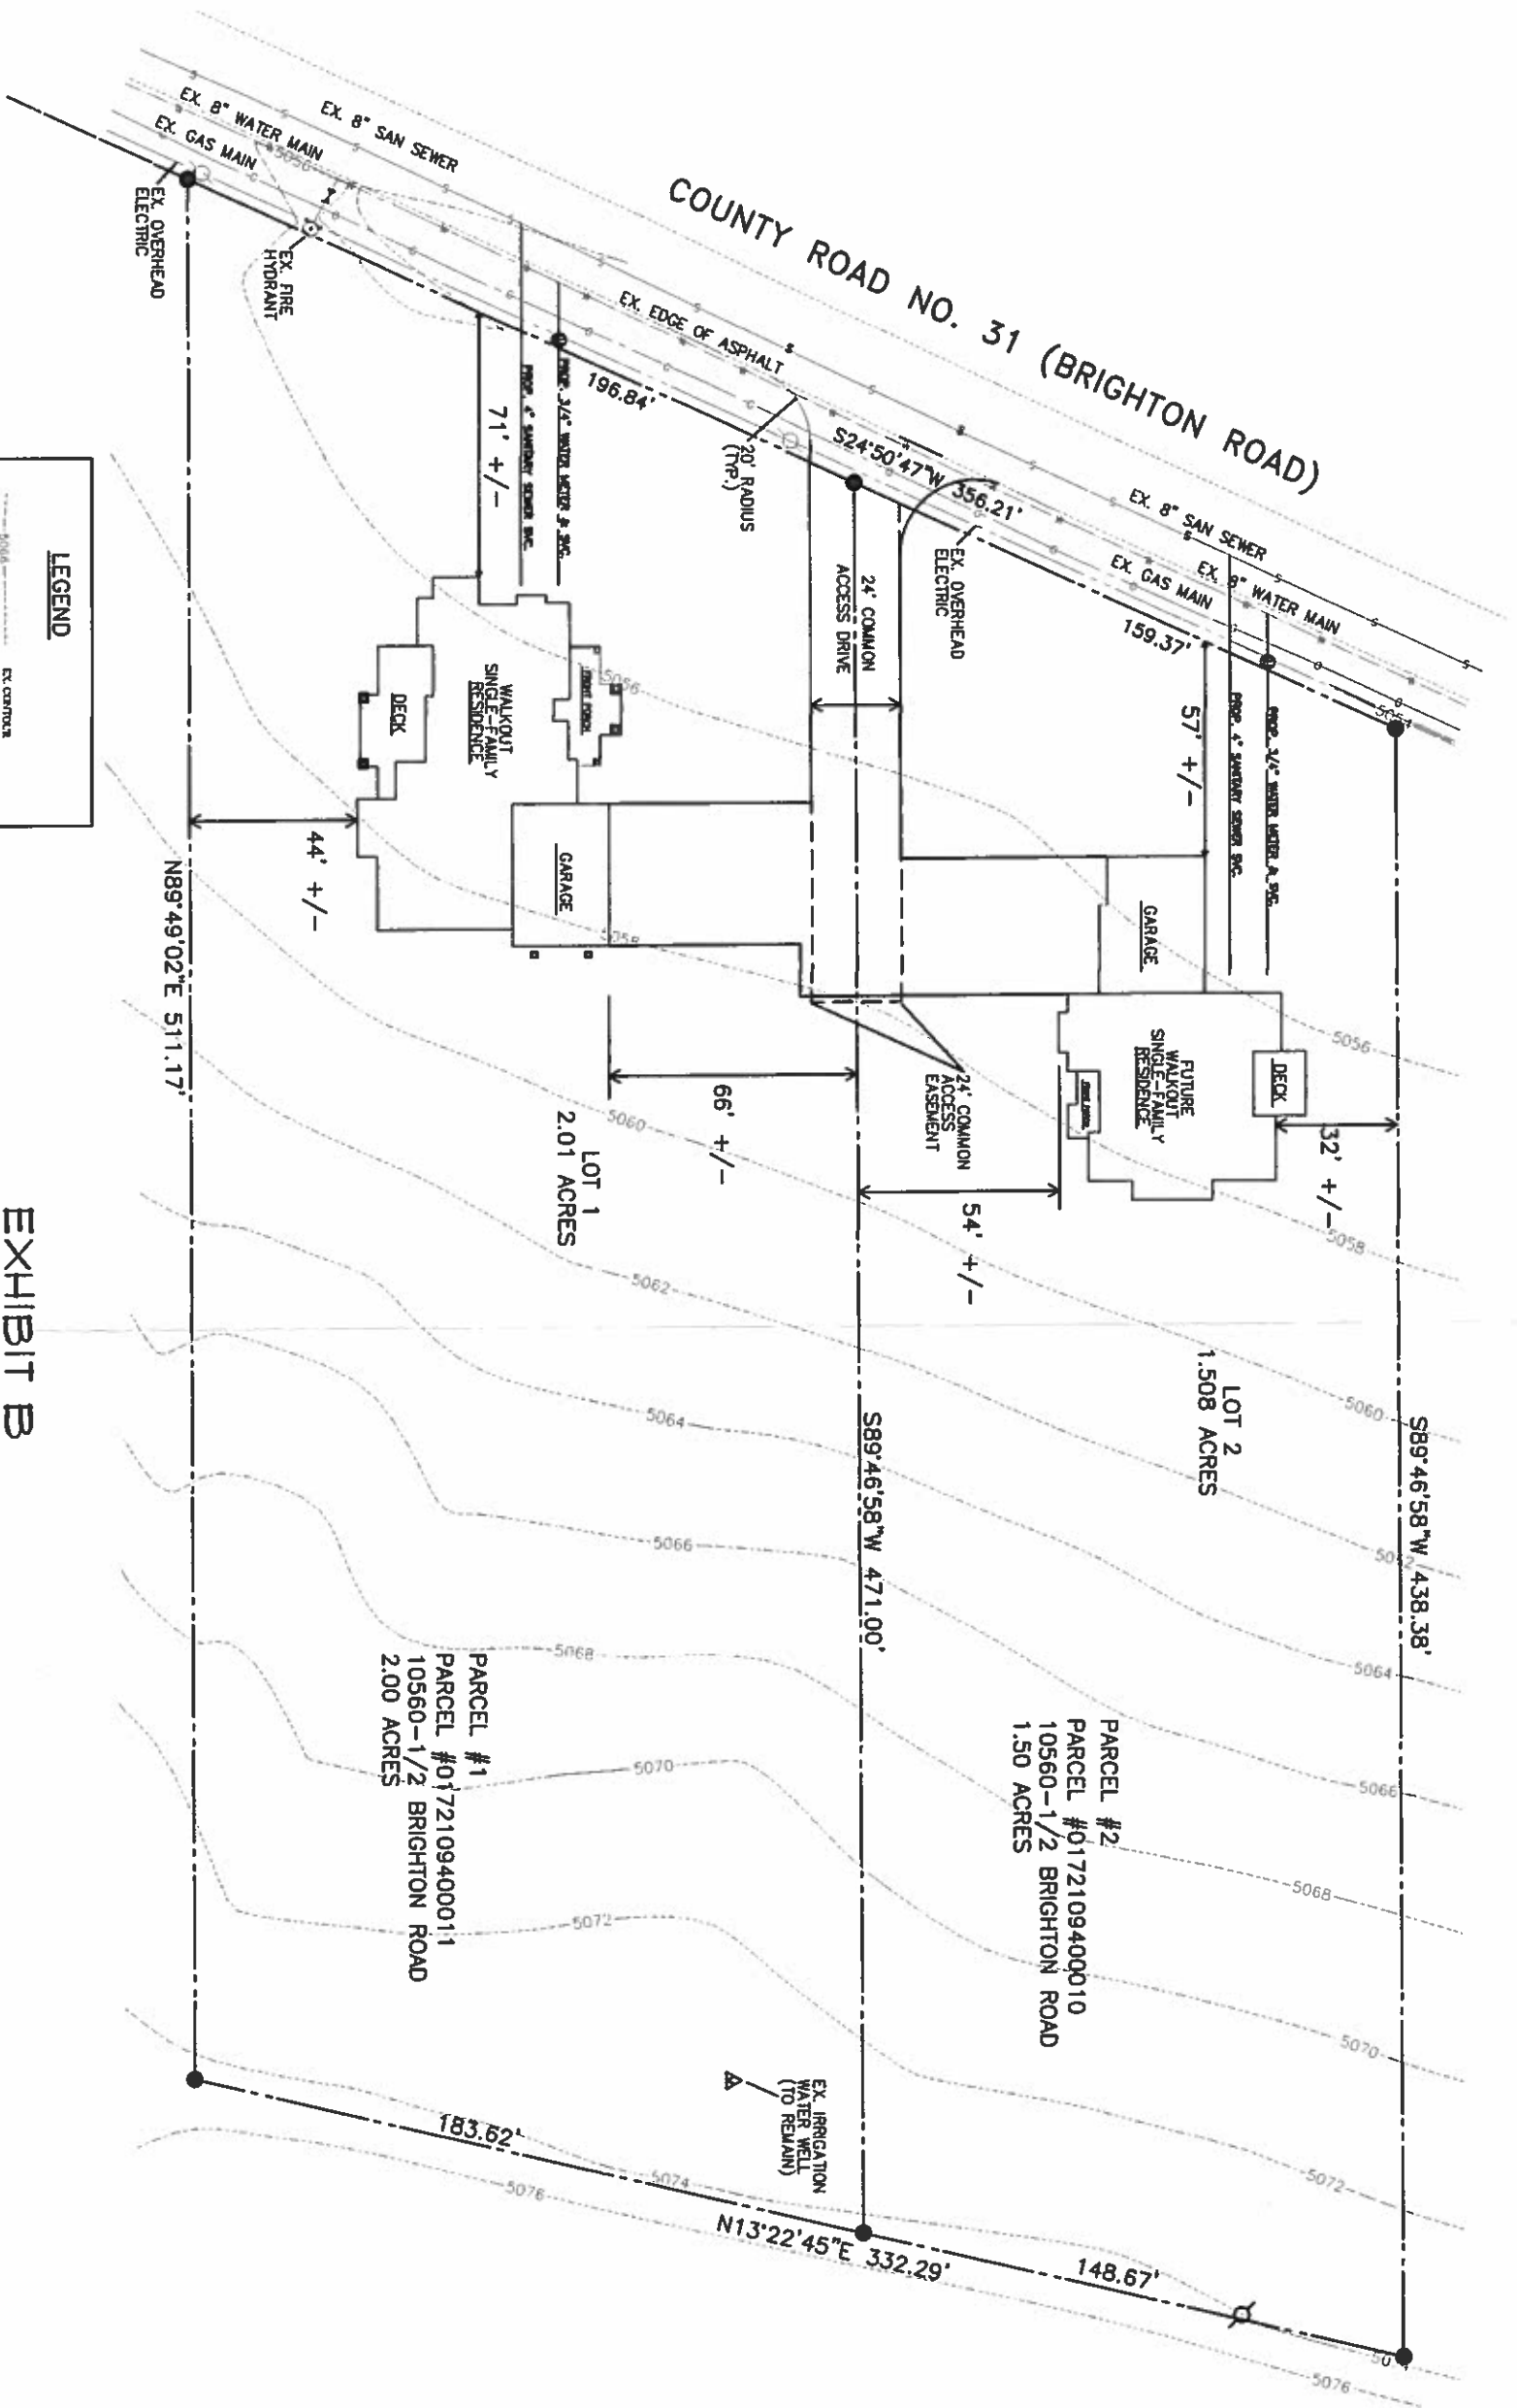

NORTH
SCALE: 1" = 50'
(FOR 11"x17")

LEGEND

- EX. CENTERLINE
- EX. EDGE OF ASPHALT
- EX. SAN SEWER MAIN
- EX. WATER MAIN
- EX. GAS MAIN
- EX. OVERHEAD ELECTRIC WITH POWER POLE
- EX. WATER VALVE AND FIRE HYDRANT

EXHIBIT B
SITE PLAN

CEB
CONSULTANTS, LLC
281 4TH STREET, SUITE 1
FT. LUTHER, CO. 80631
PH. (781) 570-4488

RONQUILLO GID INCLUSION SITE PLAN
SAUL RODRIGUEZ RONQUILLO
10560 BRIGHTON ROAD
HENDERSON, COLORADO 80640

DRAWING INFO.
REVISIONS: 1
DRAWN BY: [blank]
CHECKED BY: [blank]
DATE: [blank]
SCALE: [blank]
SHEET NO.: [blank]
OF 1