



OHLSON LAVOIE
COLLABORATIVE
www.olcdesigns.com


616 E SPEER BLVD
DENVER, COLORADO
80203-4213
T: 303.294.9244

Outdoor Leisure Pool at Pioneer Park
5959 Holly St. Commerce City, CO

NO.	DATE	TITLE/PURPOSE
1	5 August, 2014	BID SET
2	19 August, 2014	Addendum #2
3		CONSTRUCTION SET
4		
5		
6		
7		
8		
9		
10		
11		
12		

SCALE: 1/16" = 1'-0"
ISSUE DATE: 9/30/2014
DRAWN BY: AL
REVD BY: AC
PROJECT #: 14026
SHEET TITLE:
POOL PIPING PLAN

SHEET #
AQ302

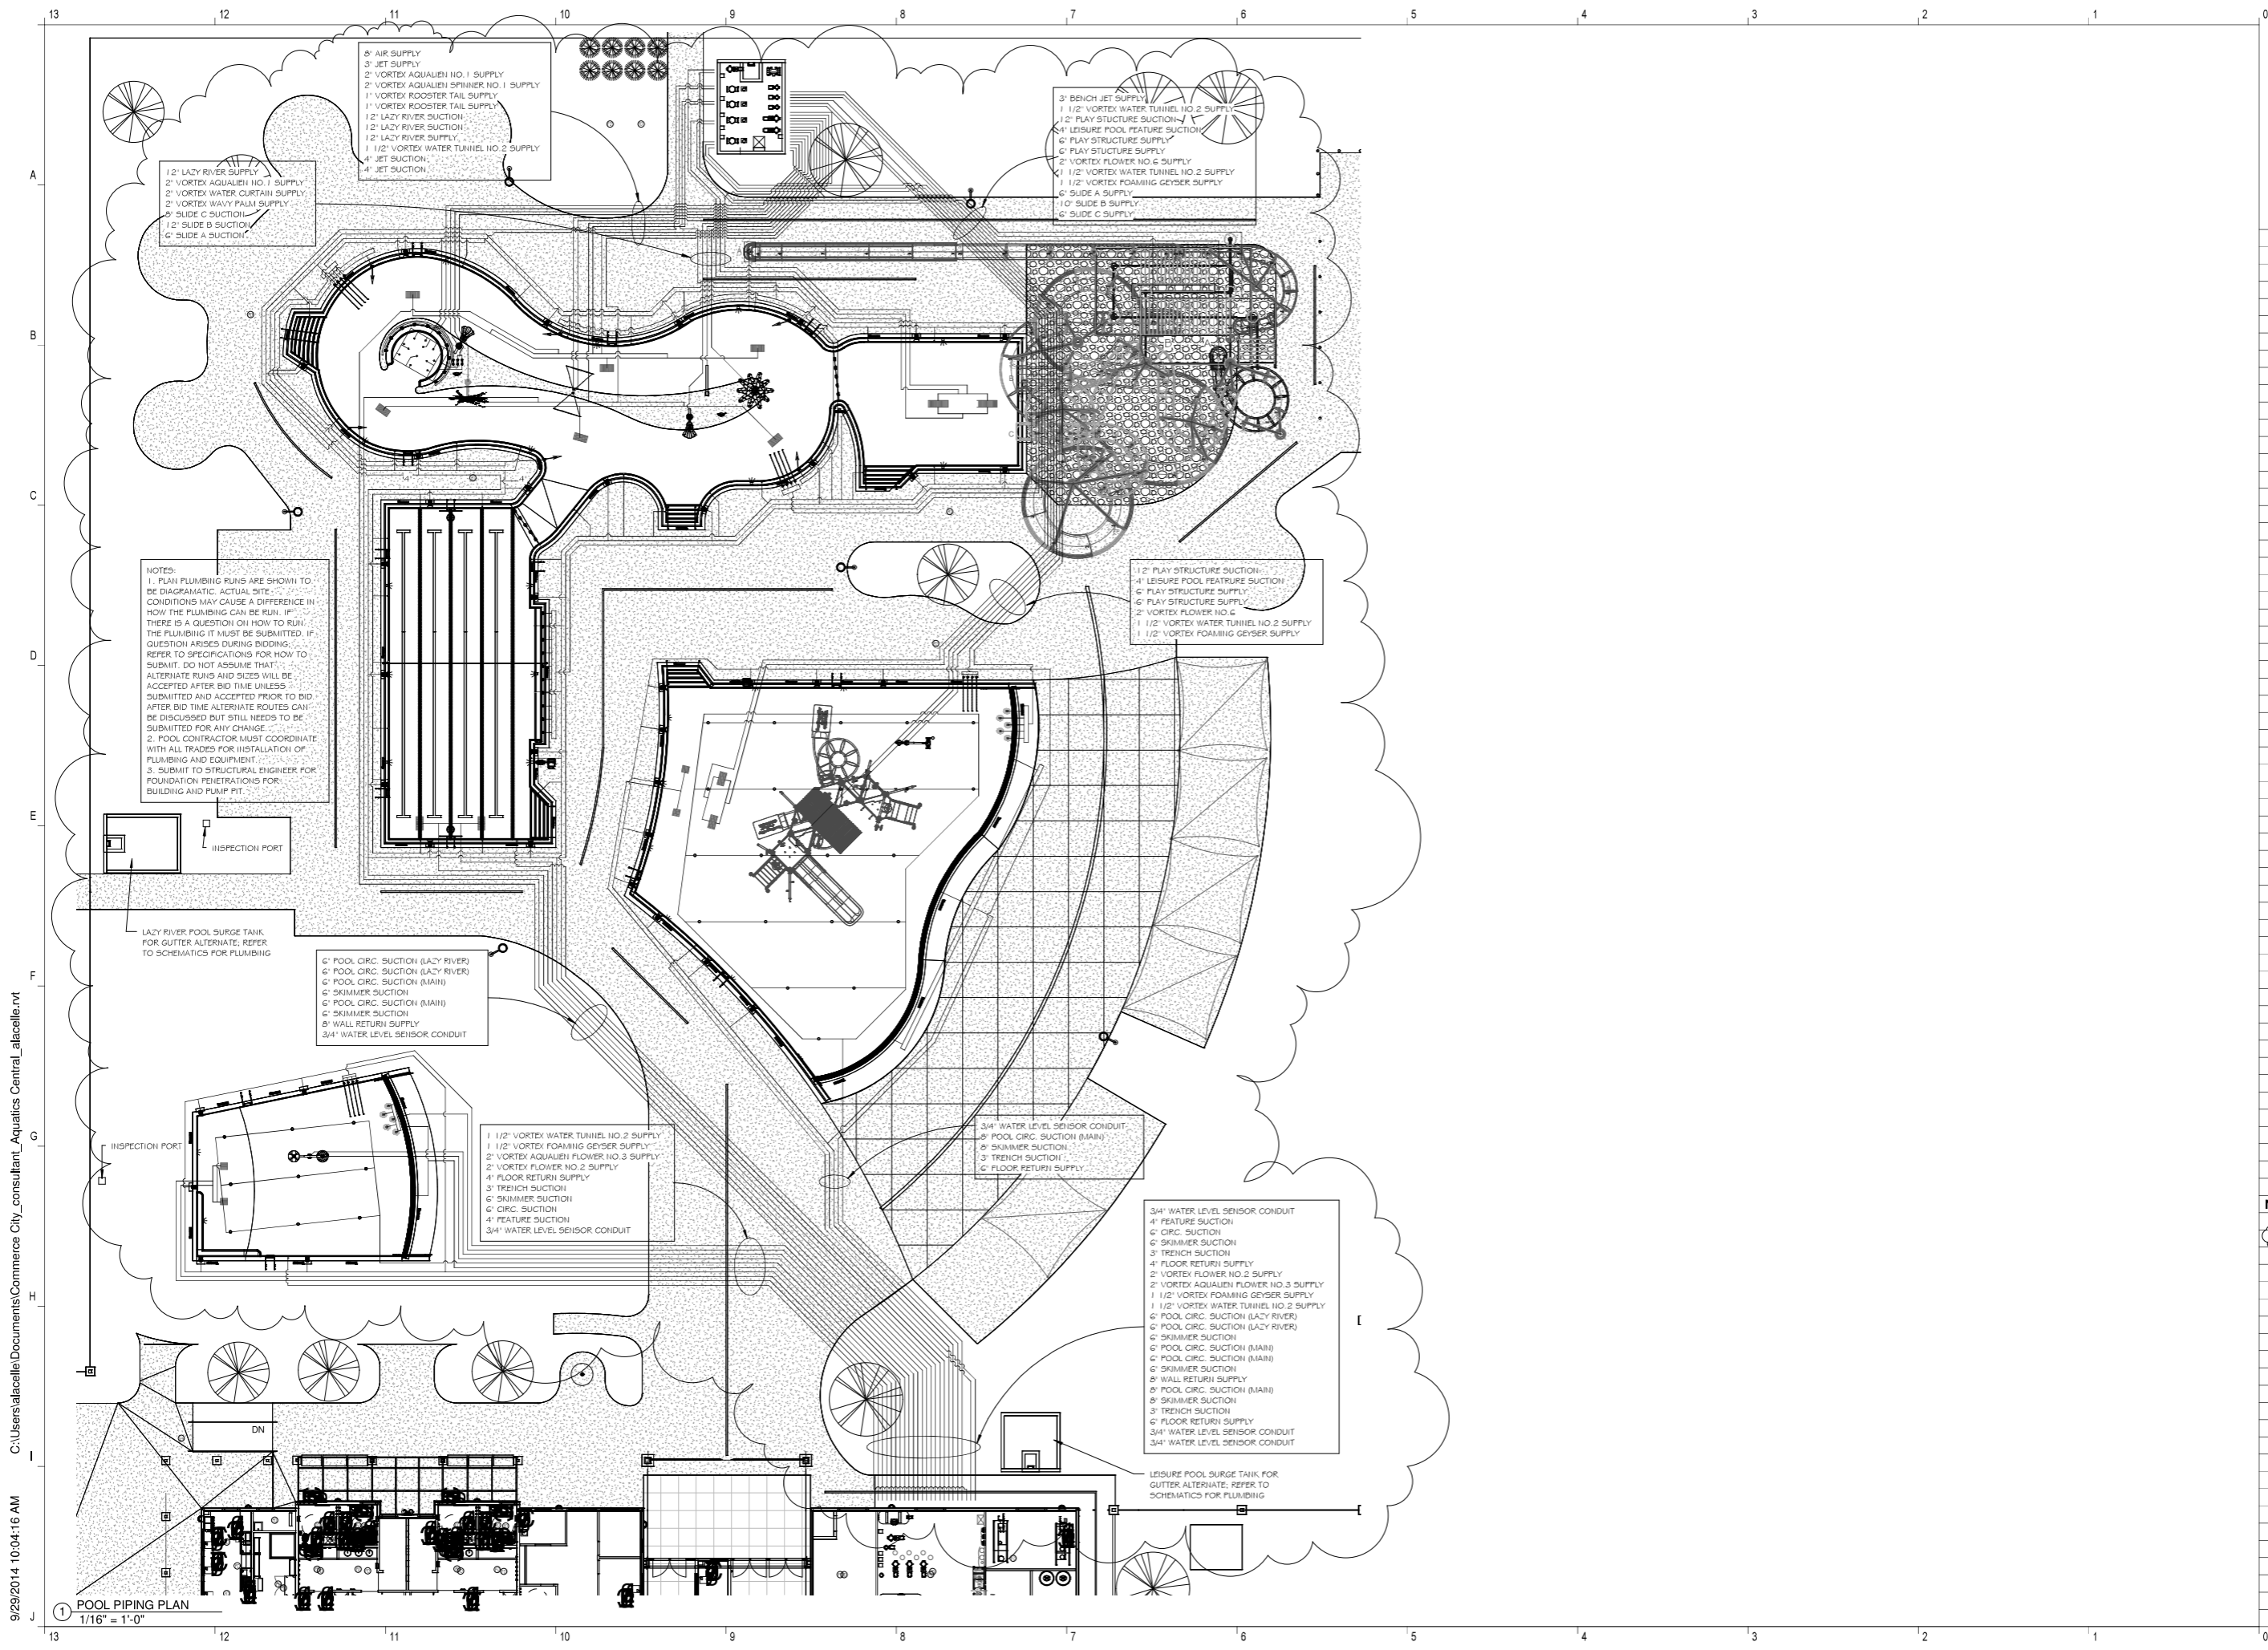

C:\Users\alacella\Documents\Commerce City Consultant_Aquatics Central_alacella.rvt

9/29/2014 10:04:16 AM